


SUPERSEDES REFERENCE
 C.M. ST. PAPER GROUP NO. A-8060
 CAR DEPARTMENT MILWAUKEE
 DATE OF THIS PRINT
 DRAWN BY
 CHECKED BY
 REVISIONS

FLOOR PLAN

NUMBERS	CLASS
1058-1061	TRUCK
	TRUCK

- DECK SIGN
- V VENTILATOR
 - DOOR-DESK LIGHT
 - ⊗ CONVENTIONAL GAS-ELECTRIC CENTER STATION
 - ELECTRIC CENTER STATION
 - ⊠ STATIONERY
 - ⊙ FLOOR DRAIN

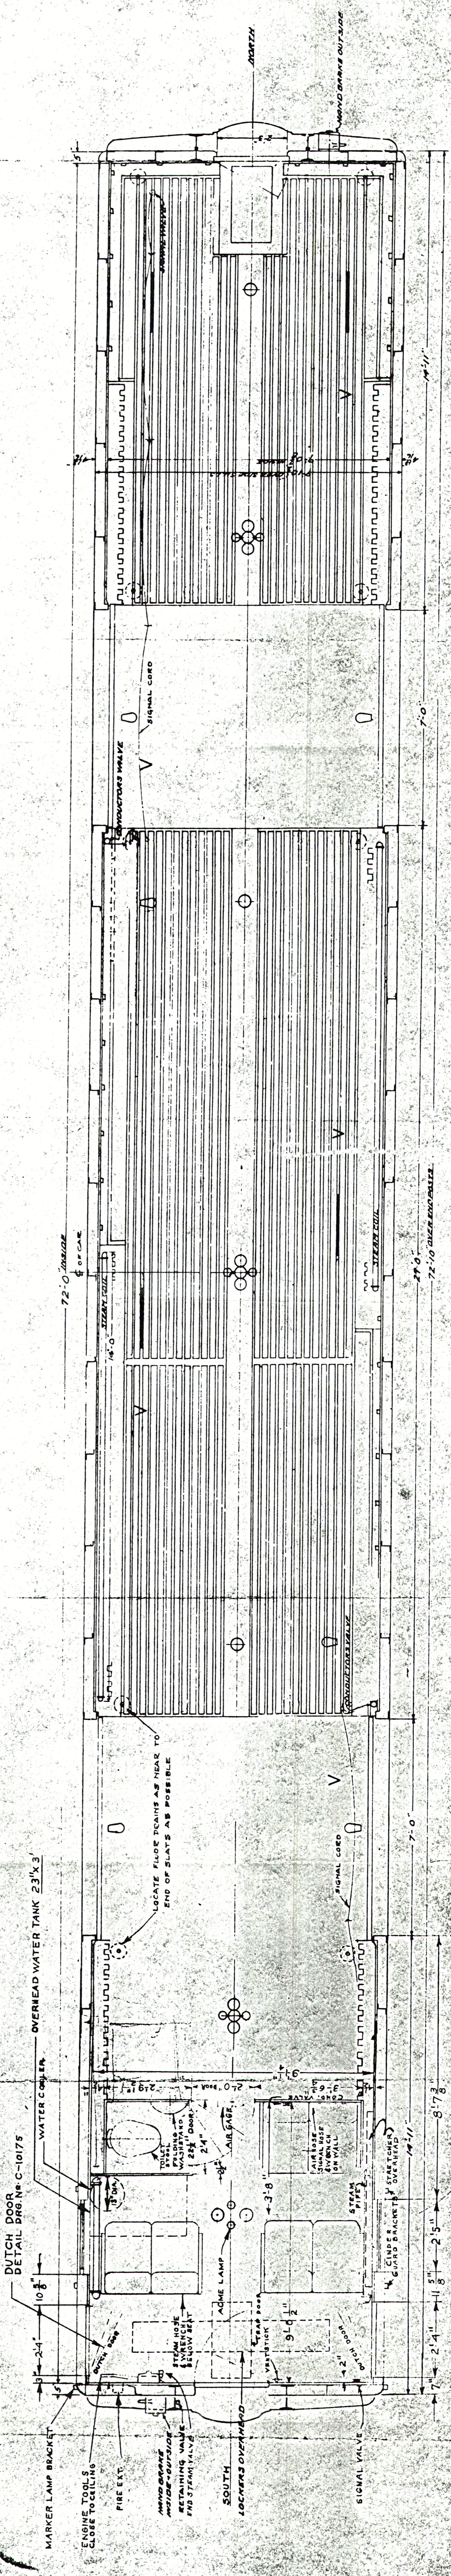

72'-10" OVERHEAD